



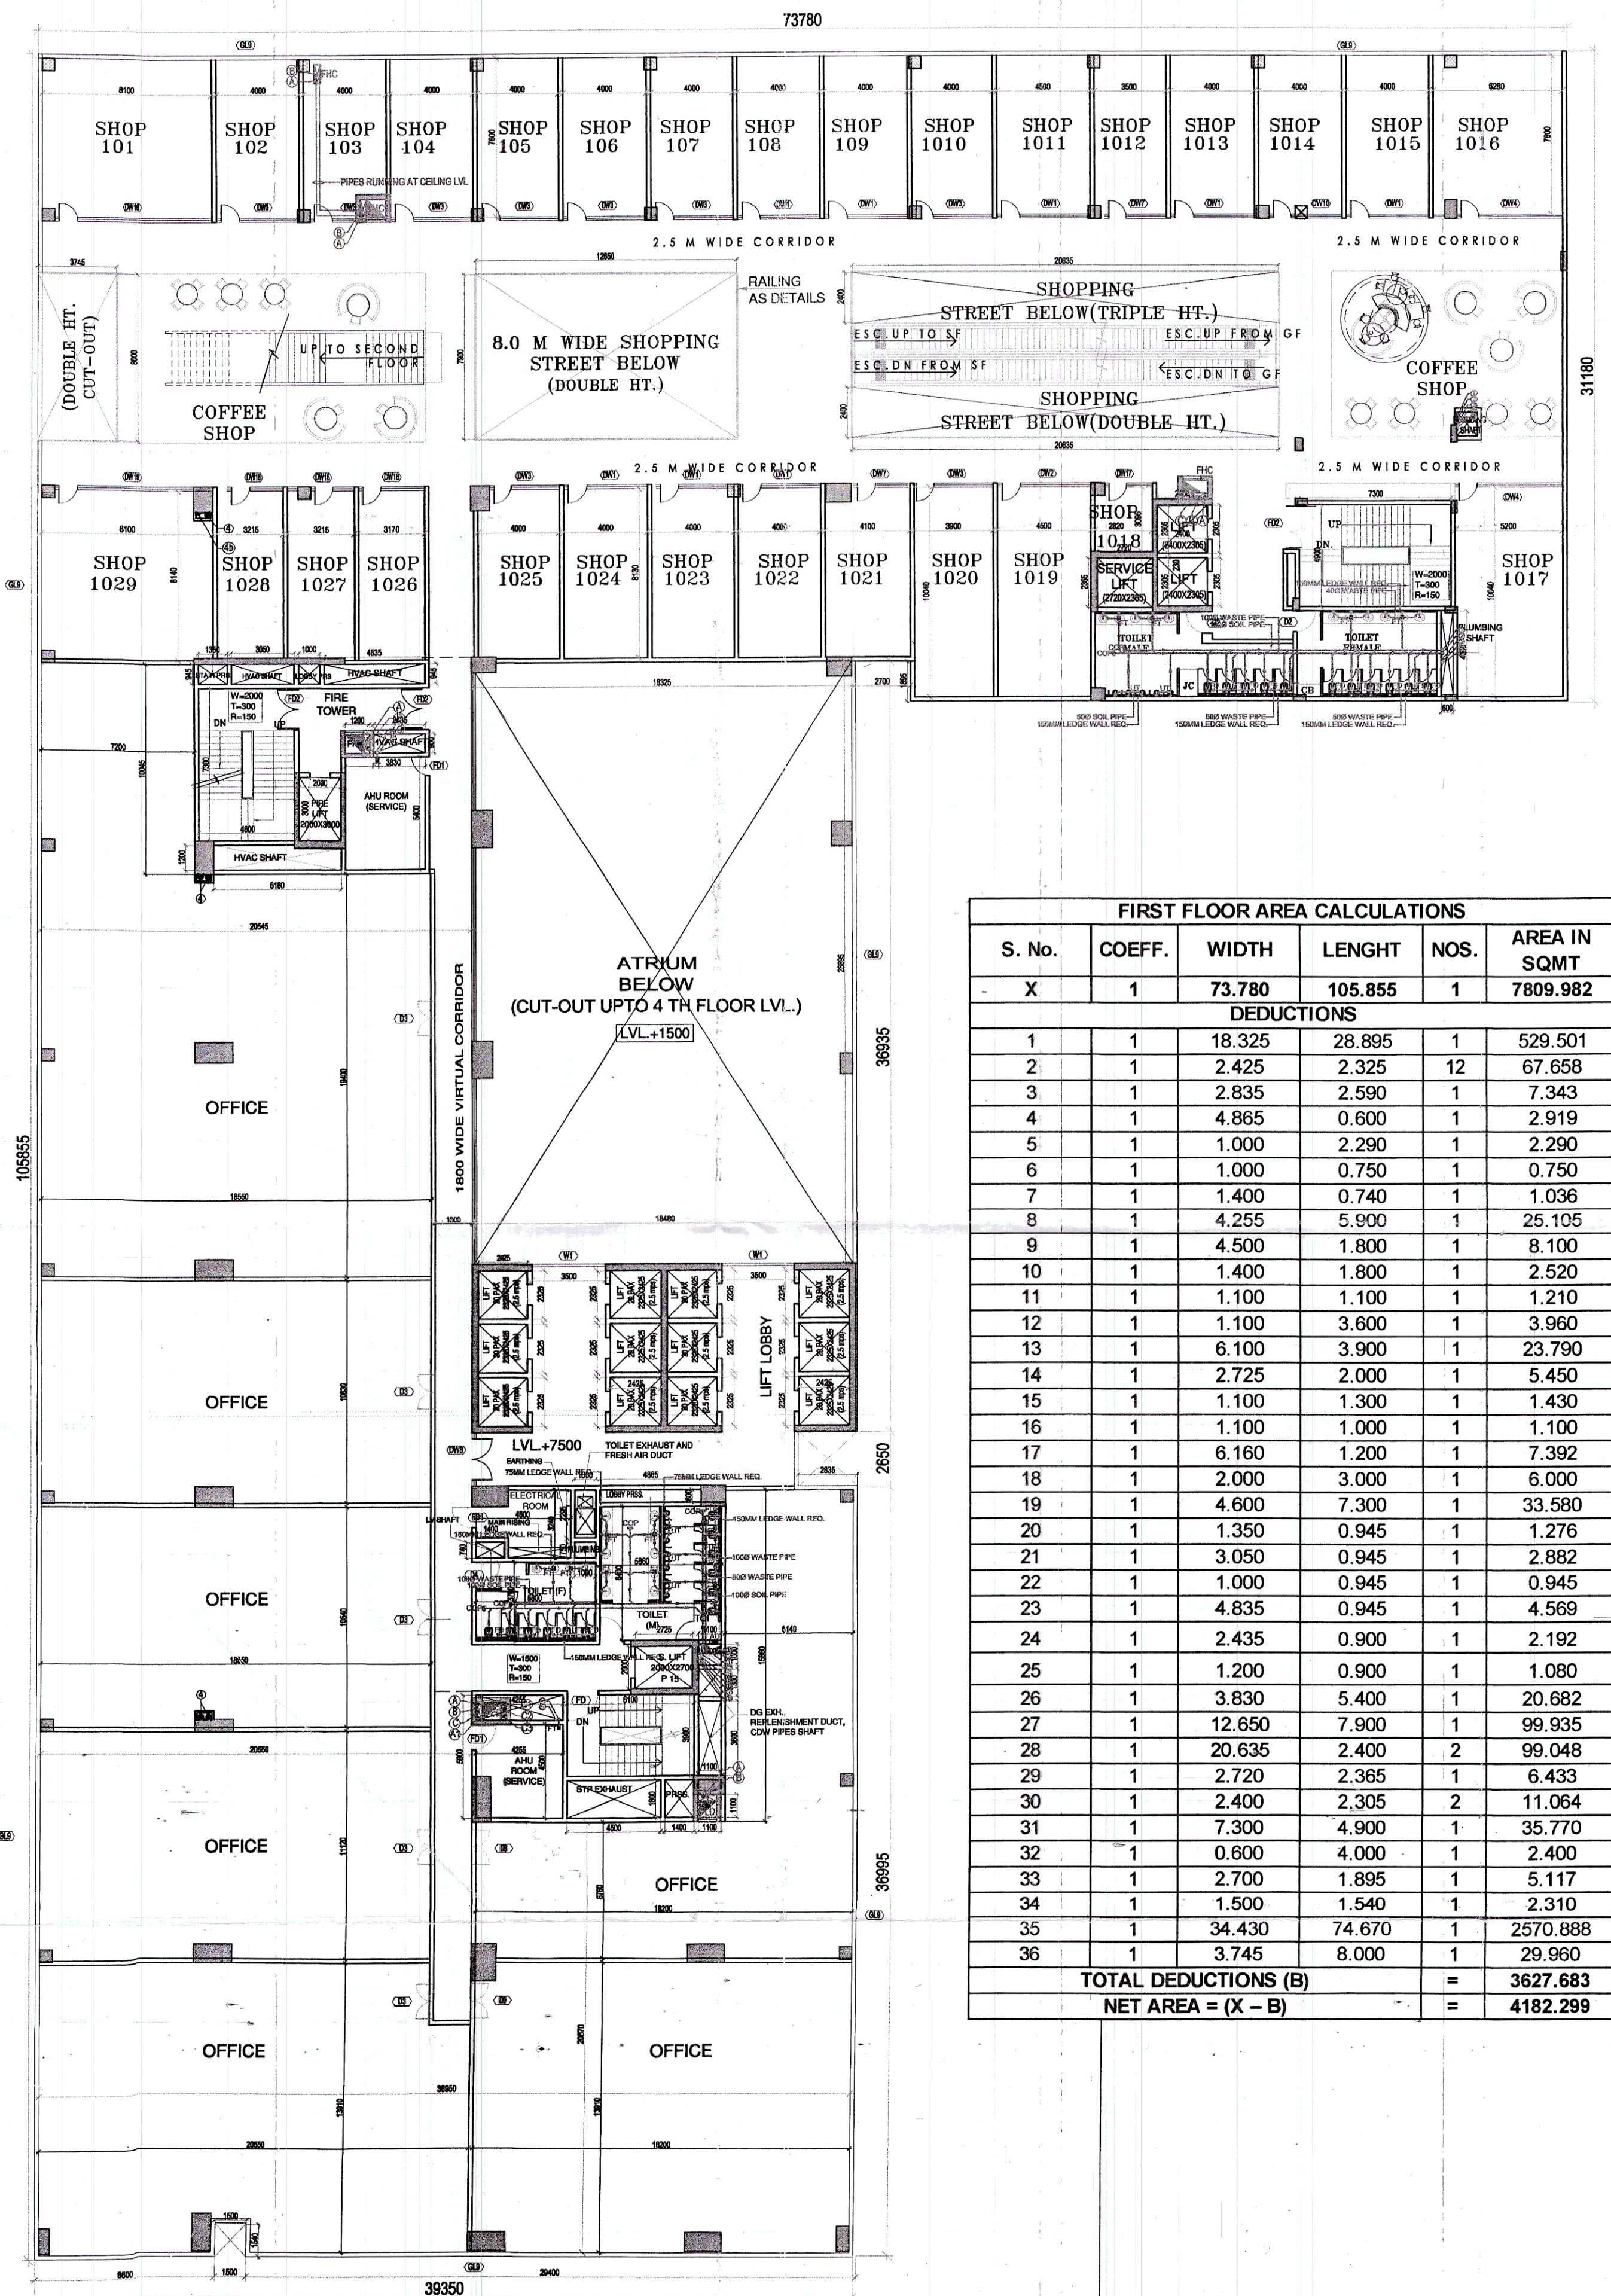

FIRST FLOOR PLAN
LVL.+7500

FIRST FLOOR AREA CALCULATIONS					
S. No.	COEFF.	WIDTH	LENGHT	NOS.	AREA IN SQMT
X	1	73.780	105.855	1	7809.982
DEDUCTIONS					
1	1	18.325	28.895	1	529.501
2	1	2.425	2.325	12	67.658
3	1	2.835	2.590	1	7.343
4	1	4.865	0.600	1	2.919
5	1	1.000	2.290	1	2.290
6	1	1.000	0.750	1	0.750
7	1	1.400	0.740	1	1.036
8	1	4.255	5.900	1	25.105
9	1	4.500	1.800	1	8.100
10	1	1.400	1.800	1	2.520
11	1	1.100	1.100	1	1.210
12	1	1.100	3.600	1	3.960
13	1	6.100	3.900	1	23.790
14	1	2.725	2.000	1	5.450
15	1	1.100	1.300	1	1.430
16	1	1.100	1.000	1	1.100
17	1	6.160	1.200	1	7.392
18	1	2.000	3.000	1	6.000
19	1	4.600	7.300	1	33.580
20	1	1.350	0.945	1	1.276
21	1	3.050	0.945	1	2.882
22	1	1.000	0.945	1	0.945
23	1	4.835	0.945	1	4.569
24	1	2.435	0.900	1	2.192
25	1	1.200	0.900	1	1.080
26	1	3.830	5.400	1	20.682
27	1	12.650	7.900	1	99.935
28	1	20.635	2.400	2	99.048
29	1	2.720	2.365	1	6.433
30	1	2.400	2.305	2	11.064
31	1	7.300	4.900	1	35.770
32	1	0.600	4.000	1	2.400
33	1	2.700	1.895	1	5.117
34	1	1.500	1.540	1	2.310
35	1	34.430	74.670	1	2570.888
36	1	3.745	8.000	1	29.960
TOTAL DEDUCTIONS (B)					3627.683
NET AREA = (X - B)					4182.299

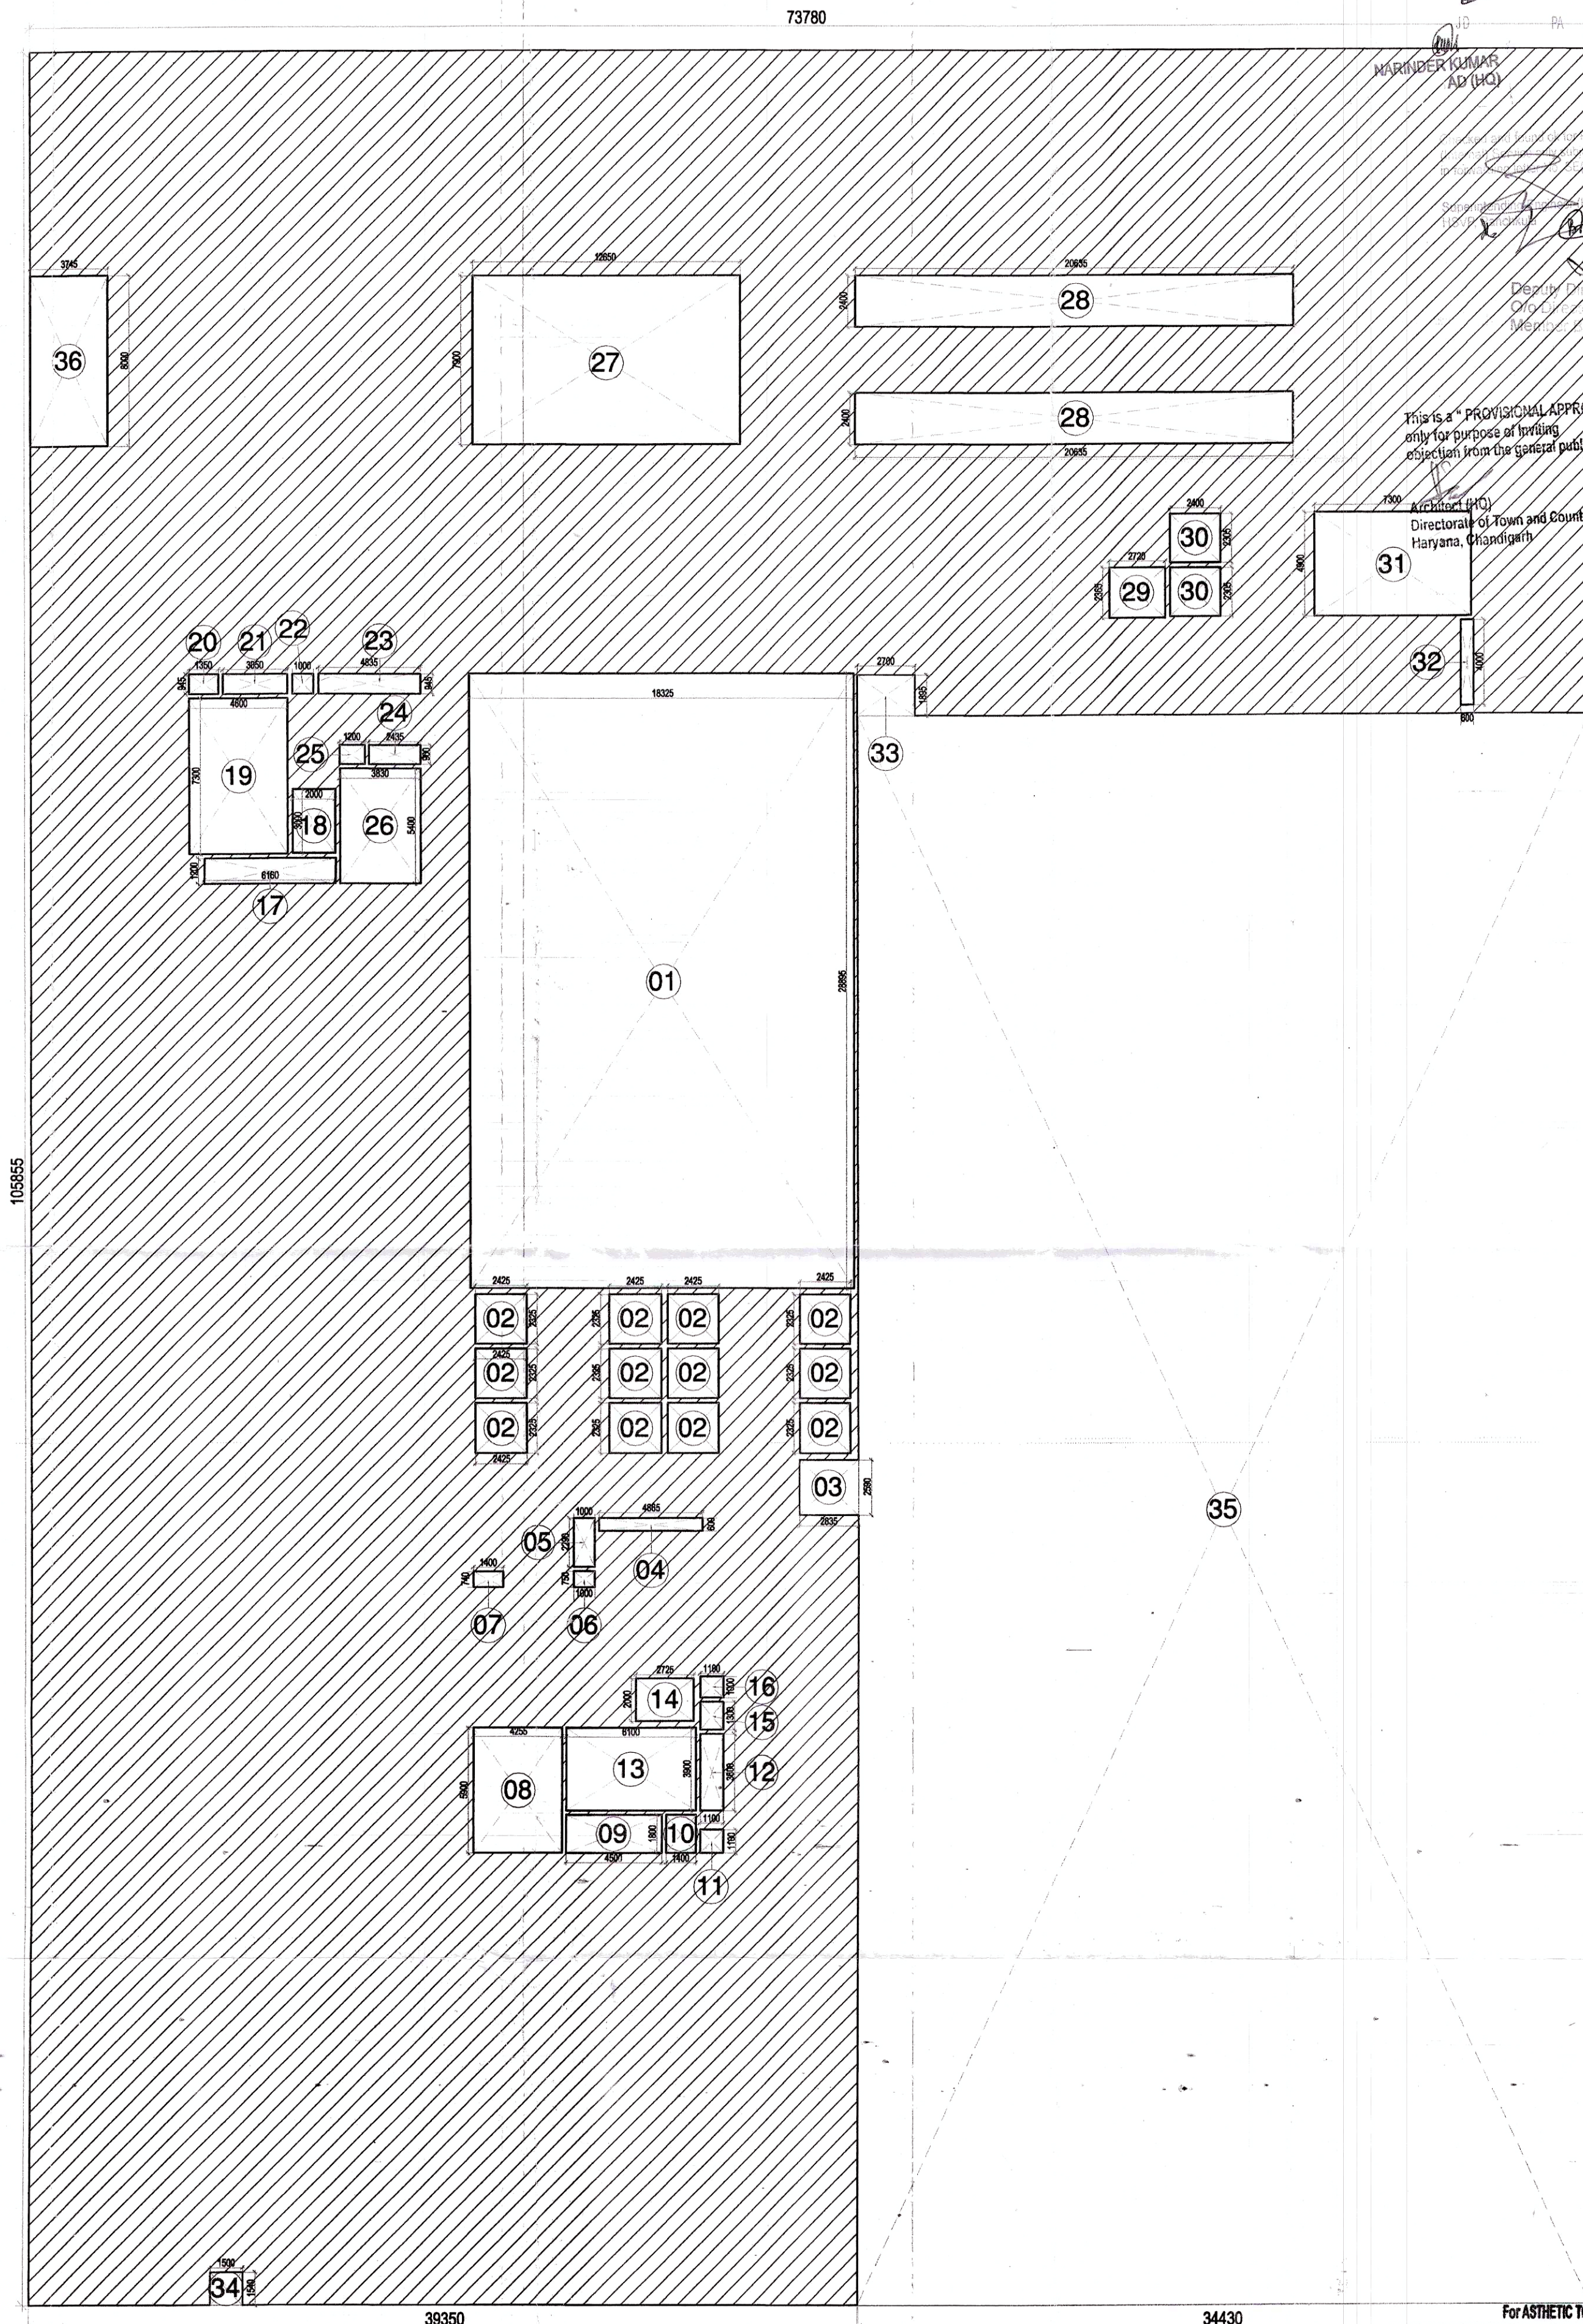


FIRST FLOOR AREA DIAGRAM

GENERAL NOTES:			
1.	WATER SUPPLY PIPE	100mm	100mm
2.	WATER SUPPLY PIPE	100mm	100mm
3.	WATER SUPPLY PIPE	100mm	100mm
4.	WATER SUPPLY PIPE	100mm	100mm
5.	WATER SUPPLY PIPE	100mm	100mm
6.	WATER SUPPLY PIPE	100mm	100mm
7.	WATER SUPPLY PIPE	100mm	100mm
8.	WATER SUPPLY PIPE	100mm	100mm
9.	WATER SUPPLY PIPE	100mm	100mm
10.	WATER SUPPLY PIPE	100mm	100mm
11.	WATER SUPPLY PIPE	100mm	100mm
12.	WATER SUPPLY PIPE	100mm	100mm
13.	WATER SUPPLY PIPE	100mm	100mm
14.	WATER SUPPLY PIPE	100mm	100mm
15.	WATER SUPPLY PIPE	100mm	100mm
16.	WATER SUPPLY PIPE	100mm	100mm
17.	WATER SUPPLY PIPE	100mm	100mm
18.	WATER SUPPLY PIPE	100mm	100mm
19.	WATER SUPPLY PIPE	100mm	100mm
20.	WATER SUPPLY PIPE	100mm	100mm
21.	WATER SUPPLY PIPE	100mm	100mm
22.	WATER SUPPLY PIPE	100mm	100mm
23.	WATER SUPPLY PIPE	100mm	100mm
24.	WATER SUPPLY PIPE	100mm	100mm
25.	WATER SUPPLY PIPE	100mm	100mm
26.	WATER SUPPLY PIPE	100mm	100mm
27.	WATER SUPPLY PIPE	100mm	100mm
28.	WATER SUPPLY PIPE	100mm	100mm
29.	WATER SUPPLY PIPE	100mm	100mm
30.	WATER SUPPLY PIPE	100mm	100mm
31.	WATER SUPPLY PIPE	100mm	100mm
32.	WATER SUPPLY PIPE	100mm	100mm
33.	WATER SUPPLY PIPE	100mm	100mm
34.	WATER SUPPLY PIPE	100mm	100mm
35.	WATER SUPPLY PIPE	100mm	100mm
36.	WATER SUPPLY PIPE	100mm	100mm

NOTES & LEGEND:			
1.	WATER SUPPLY PIPE	100mm	100mm
2.	WATER SUPPLY PIPE	100mm	100mm
3.	WATER SUPPLY PIPE	100mm	100mm
4.	WATER SUPPLY PIPE	100mm	100mm
5.	WATER SUPPLY PIPE	100mm	100mm
6.	WATER SUPPLY PIPE	100mm	100mm
7.	WATER SUPPLY PIPE	100mm	100mm
8.	WATER SUPPLY PIPE	100mm	100mm
9.	WATER SUPPLY PIPE	100mm	100mm
10.	WATER SUPPLY PIPE	100mm	100mm
11.	WATER SUPPLY PIPE	100mm	100mm
12.	WATER SUPPLY PIPE	100mm	100mm
13.	WATER SUPPLY PIPE	100mm	100mm
14.	WATER SUPPLY PIPE	100mm	100mm
15.	WATER SUPPLY PIPE	100mm	100mm
16.	WATER SUPPLY PIPE	100mm	100mm
17.	WATER SUPPLY PIPE	100mm	100mm
18.	WATER SUPPLY PIPE	100mm	100mm
19.	WATER SUPPLY PIPE	100mm	100mm
20.	WATER SUPPLY PIPE	100mm	100mm
21.	WATER SUPPLY PIPE	100mm	100mm
22.	WATER SUPPLY PIPE	100mm	100mm
23.	WATER SUPPLY PIPE	100mm	100mm
24.	WATER SUPPLY PIPE	100mm	100mm
25.	WATER SUPPLY PIPE	100mm	100mm
26.	WATER SUPPLY PIPE	100mm	100mm
27.	WATER SUPPLY PIPE	100mm	100mm
28.	WATER SUPPLY PIPE	100mm	100mm
29.	WATER SUPPLY PIPE	100mm	100mm
30.	WATER SUPPLY PIPE	100mm	100mm
31.	WATER SUPPLY PIPE	100mm	100mm
32.	WATER SUPPLY PIPE	100mm	100mm
33.	WATER SUPPLY PIPE	100mm	100mm
34.	WATER SUPPLY PIPE	100mm	100mm
35.	WATER SUPPLY PIPE	100mm	100mm
36.	WATER SUPPLY PIPE	100mm	100mm

D/W SCHEDULE			
S.NO.	TAG	SIZE	SILL LITEL
1	W1	3000 X 2400	0 2400
2	W2	5100 X 2400	0 2400
3	W3	8100 X 2400	0 2400
4	D1	750 X 2400	0 2400
5	D2	1000 X 2400	0 2400
6	D3	2000 X 2400	0 2400
7	D4	1200 X 2400	0 2400
8	D5	1500 X 2400	0 2400
9	FD	1500 X 2400	0 2400
10	FD1	1200 X 2400	0 2400
11	FD2	2000 X 2400	0 2400
12	FD3	4000 X 2400	0 2400
13	SD1	6500 X 2400	0 2400
14	SD2	3000 X 2400	0 2400
15	GL1	2886 X 2400	0 2400
16	GL2	10500 X 2400	0 2400
17	GL3	10700 X 2400	0 2400
18	GL4	7200 X 2400	0 2400
19	GL5	14645 X 2400	0 2400
20	GL6	12350 X 2400	0 2400
21	GL7	12592 X 2400	0 2400
22	GL8	14780 X 2400	0 2400
23	GL9	AS/PLAN X 2400	0 2400
24	GL10	AS/PLAN X 2400	0 2400
25	GL11	AS/PLAN X 2400	0 2400
26	GL12	15000 X 2400	0 2400
27	GL13	AS/PLAN X 2400	0 2400
28	GL14	AS/PLAN X 2400	0 2400
29	GL15	AS/PLAN X 2400	0 2400
30	GL16	AS/PLAN X 2400	0 2400
31	GL17	AS/PLAN X 2400	0 2400
32	GL18	AS/PLAN X 2400	0 2400
33	GL19	AS/PLAN X 2400	0 2400
34	GL20	AS/PLAN X 2400	0 2400
35	GL21	AS/PLAN X 2400	0 2400
36	GL22	AS/PLAN X 2400	0 2400
37	GL23	AS/PLAN X 2400	0 2400
38	DW1	4000 X 2400	0 2400
39	DW2	4500 X 2400	0 2400
40	DW3	3500 X 2400	0 2400
41	DW4	5000 X 2400	0 2400
42	DW5	4250 X 2400	0 2400
43	DW6	4150 X 2400	0 2400
44	DW7	2800 X 2400	0 2400
45	DW8	2400 X 2400	0 2400
46	DW9	6000 X 2400	0 2400
47	DW10	3400 X 2400	0 2400
48	DW11	13025 X 2400	0 2400
49	DW12	10400 X 2400	0 2400
50	DW13	10700 X 2400	0 2400
51	DW14	10500 X 2400	0 2400
52	DW15	8000 X 2400	0 2400
53	DW16	7500 X 2400	0 2400
54	DW17	2500 X 2400	0 2400
55	DW18	3000 X 2400	0 2400
56	DW19	6500 X 2400	0 2400

NOTES:
 1. ALL LIFTS SHALL HAVE 100% POWER BACKUP.
 2. ALL ELECTRICAL INSTALLATIONS SHALL BE AS PER PROVISIONS OF NEC.
 3. FIRE FIGHTING & SAFETY PROVISIONS SHALL BE AS PER RELEVANT CODE PROVISIONS.
 4. BUILDING SHALL BE DESIGNED AS PER HARYANA BUILDING CODE 2017.
 5. BUILDING SHALL BE DESIGNED AS PER HARYANA BUILDING CODE 2017.
 6. BUILDING SHALL BE DESIGNED AS PER HARYANA BUILDING CODE 2017.
 7. BUILDING SHALL BE DESIGNED AS PER HARYANA BUILDING CODE 2017.
 8. BUILDING SHALL BE DESIGNED AS PER HARYANA BUILDING CODE 2017.
 9. BUILDING SHALL BE DESIGNED AS PER HARYANA BUILDING CODE 2017.
 10. BUILDING SHALL BE DESIGNED AS PER HARYANA BUILDING CODE 2017.
 11. BUILDING SHALL BE DESIGNED AS PER HARYANA BUILDING CODE 2017.
 12. BUILDING SHALL BE DESIGNED AS PER HARYANA BUILDING CODE 2017.
 13. BUILDING SHALL BE DESIGNED AS PER HARYANA BUILDING CODE 2017.
 14. BUILDING SHALL BE DESIGNED AS PER HARYANA BUILDING CODE 2017.
 15. BUILDING SHALL BE DESIGNED AS PER HARYANA BUILDING CODE 2017.
 16. BUILDING SHALL BE DESIGNED AS PER HARYANA BUILDING CODE 2017.
 17. BUILDING SHALL BE DESIGNED AS PER HARYANA BUILDING CODE 2017.
 18. BUILDING SHALL BE DESIGNED AS PER HARYANA BUILDING CODE 2017.
 19. BUILDING SHALL BE DESIGNED AS PER HARYANA BUILDING CODE 2017.
 20. BUILDING SHALL BE DESIGNED AS PER HARYANA BUILDING CODE 2017.
 21. BUILDING SHALL BE DESIGNED AS PER HARYANA BUILDING CODE 2017.
 22. BUILDING SHALL BE DESIGNED AS PER HARYANA BUILDING CODE 2017.
 23. BUILDING SHALL BE DESIGNED AS PER HARYANA BUILDING CODE 2017.
 24. BUILDING SHALL BE DESIGNED AS PER HARYANA BUILDING CODE 2017.
 25. BUILDING SHALL BE DESIGNED AS PER HARYANA BUILDING CODE 2017.
 26. BUILDING SHALL BE DESIGNED AS PER HARYANA BUILDING CODE 2017.
 27. BUILDING SHALL BE DESIGNED AS PER HARYANA BUILDING CODE 2017.
 28. BUILDING SHALL BE DESIGNED AS PER HARYANA BUILDING CODE 2017.
 29. BUILDING SHALL BE DESIGNED AS PER HARYANA BUILDING CODE 2017.
 30. BUILDING SHALL BE DESIGNED AS PER HARYANA BUILDING CODE 2017.
 31. BUILDING SHALL BE DESIGNED AS PER HARYANA BUILDING CODE 2017.
 32. BUILDING SHALL BE DESIGNED AS PER HARYANA BUILDING CODE 2017.
 33. BUILDING SHALL BE DESIGNED AS PER HARYANA BUILDING CODE 2017.
 34. BUILDING SHALL BE DESIGNED AS PER HARYANA BUILDING CODE 2017.
 35. BUILDING SHALL BE DESIGNED AS PER HARYANA BUILDING CODE 2017.
 36. BUILDING SHALL BE DESIGNED AS PER HARYANA BUILDING CODE 2017.

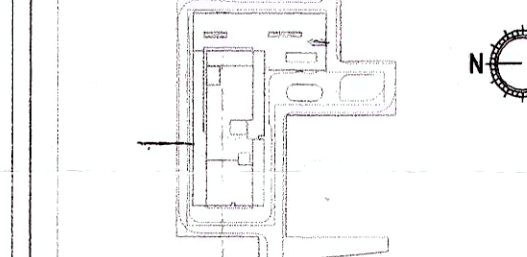

PRINCIPAL ARCHITECT:
ACPL
 ACPL Design Ltd
 100, Sector 27, Gurugram, Haryana
 122001
 Phone: +91 122 4000000
 Email: info@acpl.co.in
 Website: www.acpl.co.in

PROJECT:
 REVISED BUILDING PLAN FOR COMMERCIAL COLONY MEASURING 2.81 ACRES, IN SECTOR 27, GURUGRAM MANESAR URBAN COMPLEX BEING DEVELOPED BY M/S ASTHETIC TOWNSHIP DEVELOPERS PVT. LTD. AND OTHERS (LICENCE NO. 97 OF 2011 DATED 06-11-2011)

OWNER AUTH. SIGNATURE: _____
 ARCHITECT'S SIGNATURE: _____
 DRAWING TITLE: FIRST FLOOR PLAN & AREA CALCULATIONS
 DRAWING NO.: A-07 SCALE: 1:150